

- 01 REFRIGERATION PIPES RISER TO SECOND FLOOR CEILING SPACE.
- 02 REFRIGERATION PIPES IN CEILING SPACE.
- 03 REFRIGERATION PIPES IN GMS TRUNKING.
- 04 Ø25mm DRAIN PIPE.
- 05 Ø40mm DRAIN PIPE.
- 06 Ø50mm DRAIN PIPE DROPPER TO LGF.

NOTES:
 1. FINAL MEASUREMENTS SHALL BE TAKEN ON SITE BEFORE MANUFACTURING.
 2. A/C UNITS ARE DAIKIN.

- LEGEND:**
- REFRIGERATION PIPES
 - DRAIN PIPES
 - CEILING CASSETTE UNIT
 - HIGH WALL UNIT
 - SPLIT CONDENSING UNIT
 - VRV CONDENSING UNIT
 - EXTRACT/SUPPLY AIR FAN
 - ROUND DAMPER
 - RECTANGULAR DAMPER
 - CEILING DIFFUSER
 - RETURN AIR GRILLE

THIS DRAWING IS TO BE USED FOR MECHANICAL SERVICES ONLY

| No. | DATE | DESCRIPTION | APPROVED |
|-----|----------|---------------------------|----------|
| 4 | 03/03/23 | ADD NEW SCC VRV CONDENSER | |
| 3 | 14/05/18 | AS BUILT | |
| 2 | 14/07/17 | REVISED FAN NUMBERS | |
| 1 | 23/06/17 | FOR CONSTRUCTION | |
| 0 | 25/05/16 | FOR TENDER PURPOSES ONLY. | |

AMENDMENTS


CLIENT:



NSFAF
 Namibia Students Financial Assistance Fund

P.O. BOX 23053
 WINDHOEK
 NAMIBIA

Tel.: 061 420 647

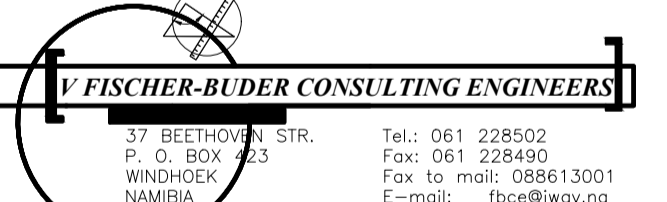

V. FISCHER-BUDER CONSULTING ENGINEERS

37 BEEHÖVEN STR.
 P. O. BOX 23053
 WINDHOEK
 NAMIBIA

Tel.: 061 228502
 Fax: 061 228490
 Fax to mail: 088613001
 E-mail: vfce@vfyw.na

| | | |
|-----------|------------|---------------------|
| DATE: | 30/06/2014 | CLIENT: |
| DESIGNED: | VF-B | CONSULTING ENGINEER |
| DRAWN: | G.R. | |
| CHECKED: | VF-B | |

MAIN TITLE :
 NEW HEAD OFFICE:
 NAMIBIA STUDENT
 FINANCIAL ASSISTANCE
 FUND

SUB TITLE :
 HVAC LAYOUT:
 HEAD OFFICE,
 SECOND FLOOR

SCALE
 AS SHOWN

DRAWING No.
 1167/MG/108 **4**

SECOND FLOOR LAYOUT:
 SCALE 1:100